



Architecture | Planning | Interiors  
 434 5th Street, Suite 1  
 Brookings, SD 57006 | P: 605.692.4008  
 2301 W. Russell St. Suite 1  
 Sioux Falls, SD 57104 | P: 605.692.4008

STAMP:

**PRELIMINARY PLANS**

NOT FOR CONSTRUCTION



**1 BUILDING ELEVATION - NORTH**  
 1" = 10'-0"

1




**2 BUILDING ELEVATION - SOUTH**  
 1" = 10'-0"

2



**3 BUILDING ELEVATION - WEST**  
 1" = 10'-0"

3

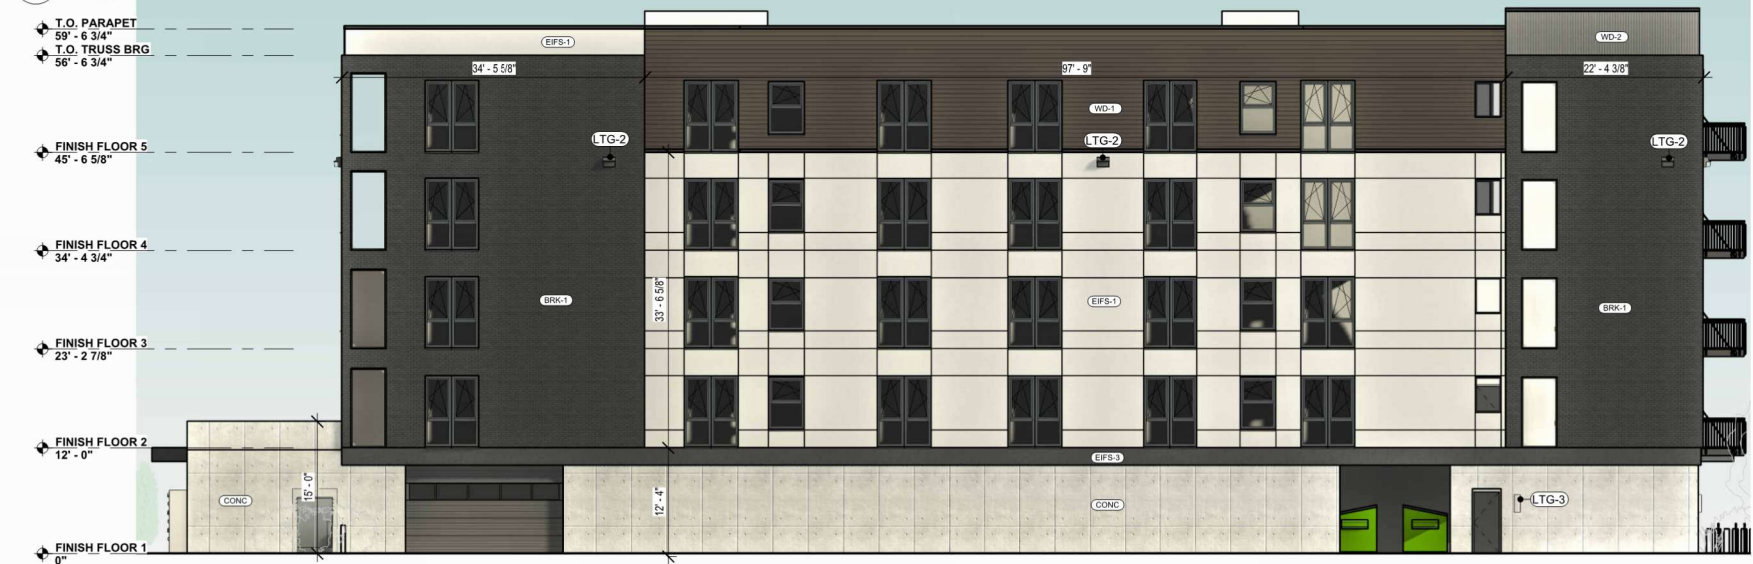

**4 BUILDING ELEVATION - EAST**  
 1" = 10'-0"

4

EXTERIOR MATERIALS LEGEND		
MATERIAL ABBREVIATION	MATERIAL DESCRIPTION	COMMENTS
BRK-1	BRICK	Color TBD
CONC	ARCHITECTURAL PRECAST	Color TBD
EFS-1	EIFS	Color TBD
EFS-2	EIFS	Color TBD
WD-1	WOOD SIDING, HORIZONTAL	Color TBD
WD-2	WOOD SIDING, VERTICAL	Color TBD

LIGHTING FIXTURE SCHEDULE		
Type Mark	Count	Description
LTG-1	2	LED POLE LIGHTING
LTG-2	12	LED WALL PACK LIGHTING
LTG-3	8	LED WALL WASHER LIGHTING

PLANTING SCHEDULE		
Type Mark	Count	Description
LAN-1	11	HONEY LOCUST TREE - 1.5" CALIPE
LAN-2	7	LOMBARDY POPLAR
LAN-3	12	HYDRANGEA INCREDIBALL
LAN-4	19	HAPPY RETURN DAYLILLY
LAN-5	18	KARL FOESTER GRASS

DATE:

REVISIONS:  
 NO. DESCRIPTION:

SHEET NAME:  
**BUILDING ELEVATIONS**

FULL SCALE: 24x36  
 DRAWING MAY NOT BE PRINTED TO SCALE

PROJECT NO.  
 DA23-074

**CAMPANILE FLATS**

BROOKINGS, SD

PROJECT MANAGER:  
 HERMELA ABOYE

DATE:  
 04.25.2024

SHEET:

**A2.1**

**PRELIMINARY PLANS - NOT FOR CONSTRUCTION**