



Architecture | Planning | Interiors
 434 5th Street, Suite 1
 Brookings, SD 57006 | P: 605.692.4008
 2301 W. Russell St. Suite 1
 Sioux Falls, SD 57104 | P: 605.692.4008

STAMP:

PRELIMINARY PLANS

NOT FOR CONSTRUCTION




1 BUILDING ELEVATION - NORTH
 1" = 10'-0"

1



3 BUILDING ELEVATION - WEST
 1" = 10'-0"

3

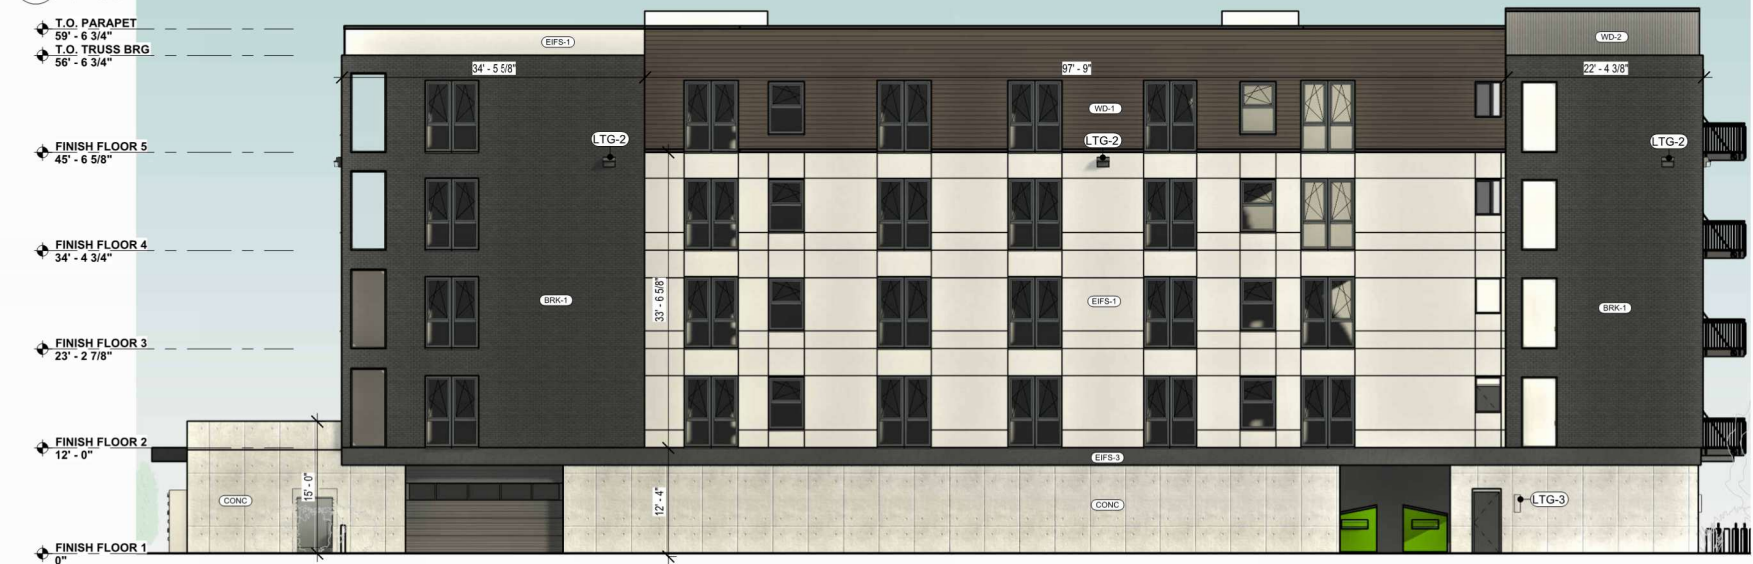

4 BUILDING ELEVATION - EAST
 1" = 10'-0"

4

DATE PRINTED: 4/25/2024 3:54:42 PM



2 BUILDING ELEVATION - SOUTH
 1" = 10'-0"

2

EXTERIOR MATERIALS LEGEND		
MATERIAL ABBREVIATION	MATERIAL DESCRIPTION	COMMENTS
BRK-1	BRICK	Color TBD
CONC	ARCHITECTURAL PRECAST	Color TBD
EFS-1	EIFS	Color TBD
EFS-2	EIFS	Color TBD
WD-1	WOOD SIDING, HORIZONTAL	Color TBD
WD-2	WOOD SIDING, VERTICAL	Color TBD

LIGHTING FIXTURE SCHEDULE		
Type Mark	Count	Description
LTG-1	2	LED POLE LIGHTING
LTG-2	12	LED WALL PACK LIGHTING
LTG-3	8	LED WALL WASHER LIGHTING

PLANTING SCHEDULE		
Type Mark	Count	Description
LAN-1	11	HONEY LOCUST TREE - 1.5" CALIPE
LAN-2	7	LOMBARDY POPLAR
LAN-3	12	HYDRANGEA INCREDIBALL
LAN-4	19	HAPPY RETURN DAYLILLY
LAN-5	18	KARL FOESTER GRASS

DATE:

REVISIONS:
NO. DESCRIPTION:

SHEET NAME:
BUILDING ELEVATIONS

FULL SCALE: 24x36
DRAWING MAY NOT BE PRINTED TO SCALE

PROJECT NO.
DA23-074

CAMPANILE FLATS

BROOKINGS, SD

PROJECT MANAGER:
HERMELA ABOYE

DATE:
04.25.2024

SHEET:

A2.1

PRELIMINARY PLANS - NOT FOR CONSTRUCTION